
 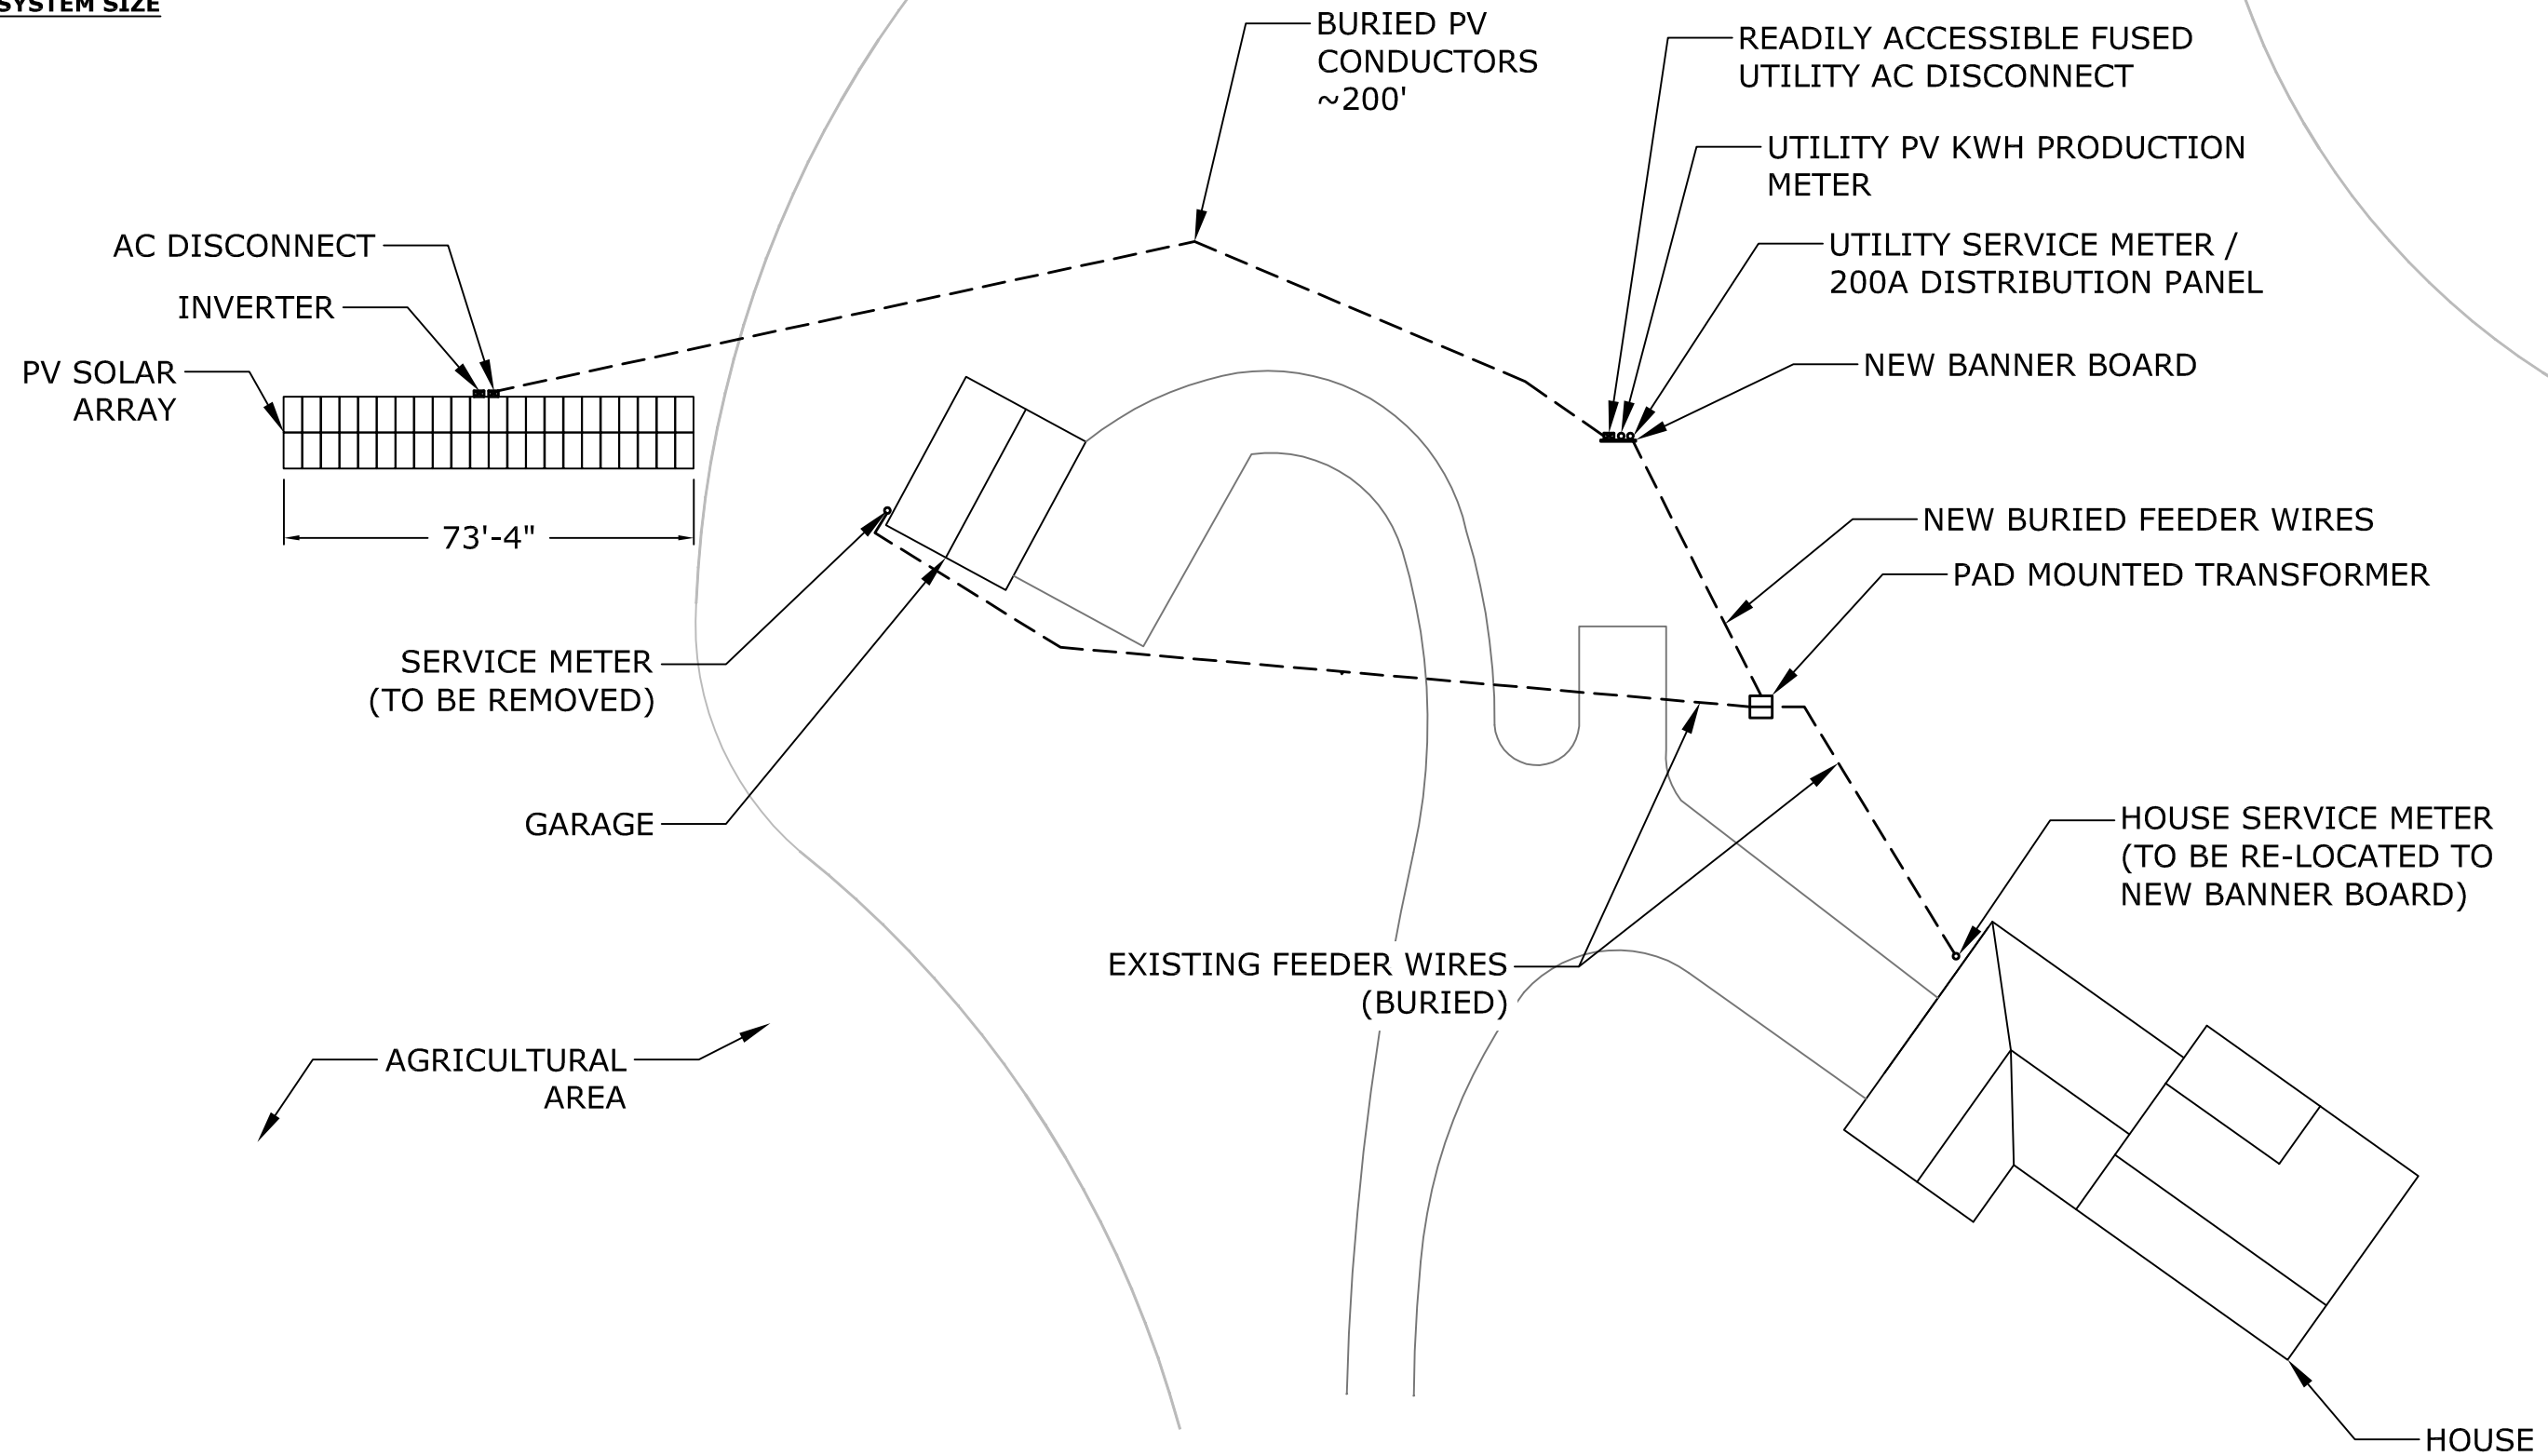


SYSTEM SIZE



		ELECTRICAL CONTRACTOR:	CUSTOMER INFORMATION:	SCALE:	PAGE: SITE PLAN
				DRAWN BY:	5/24/2018 REVISION: A